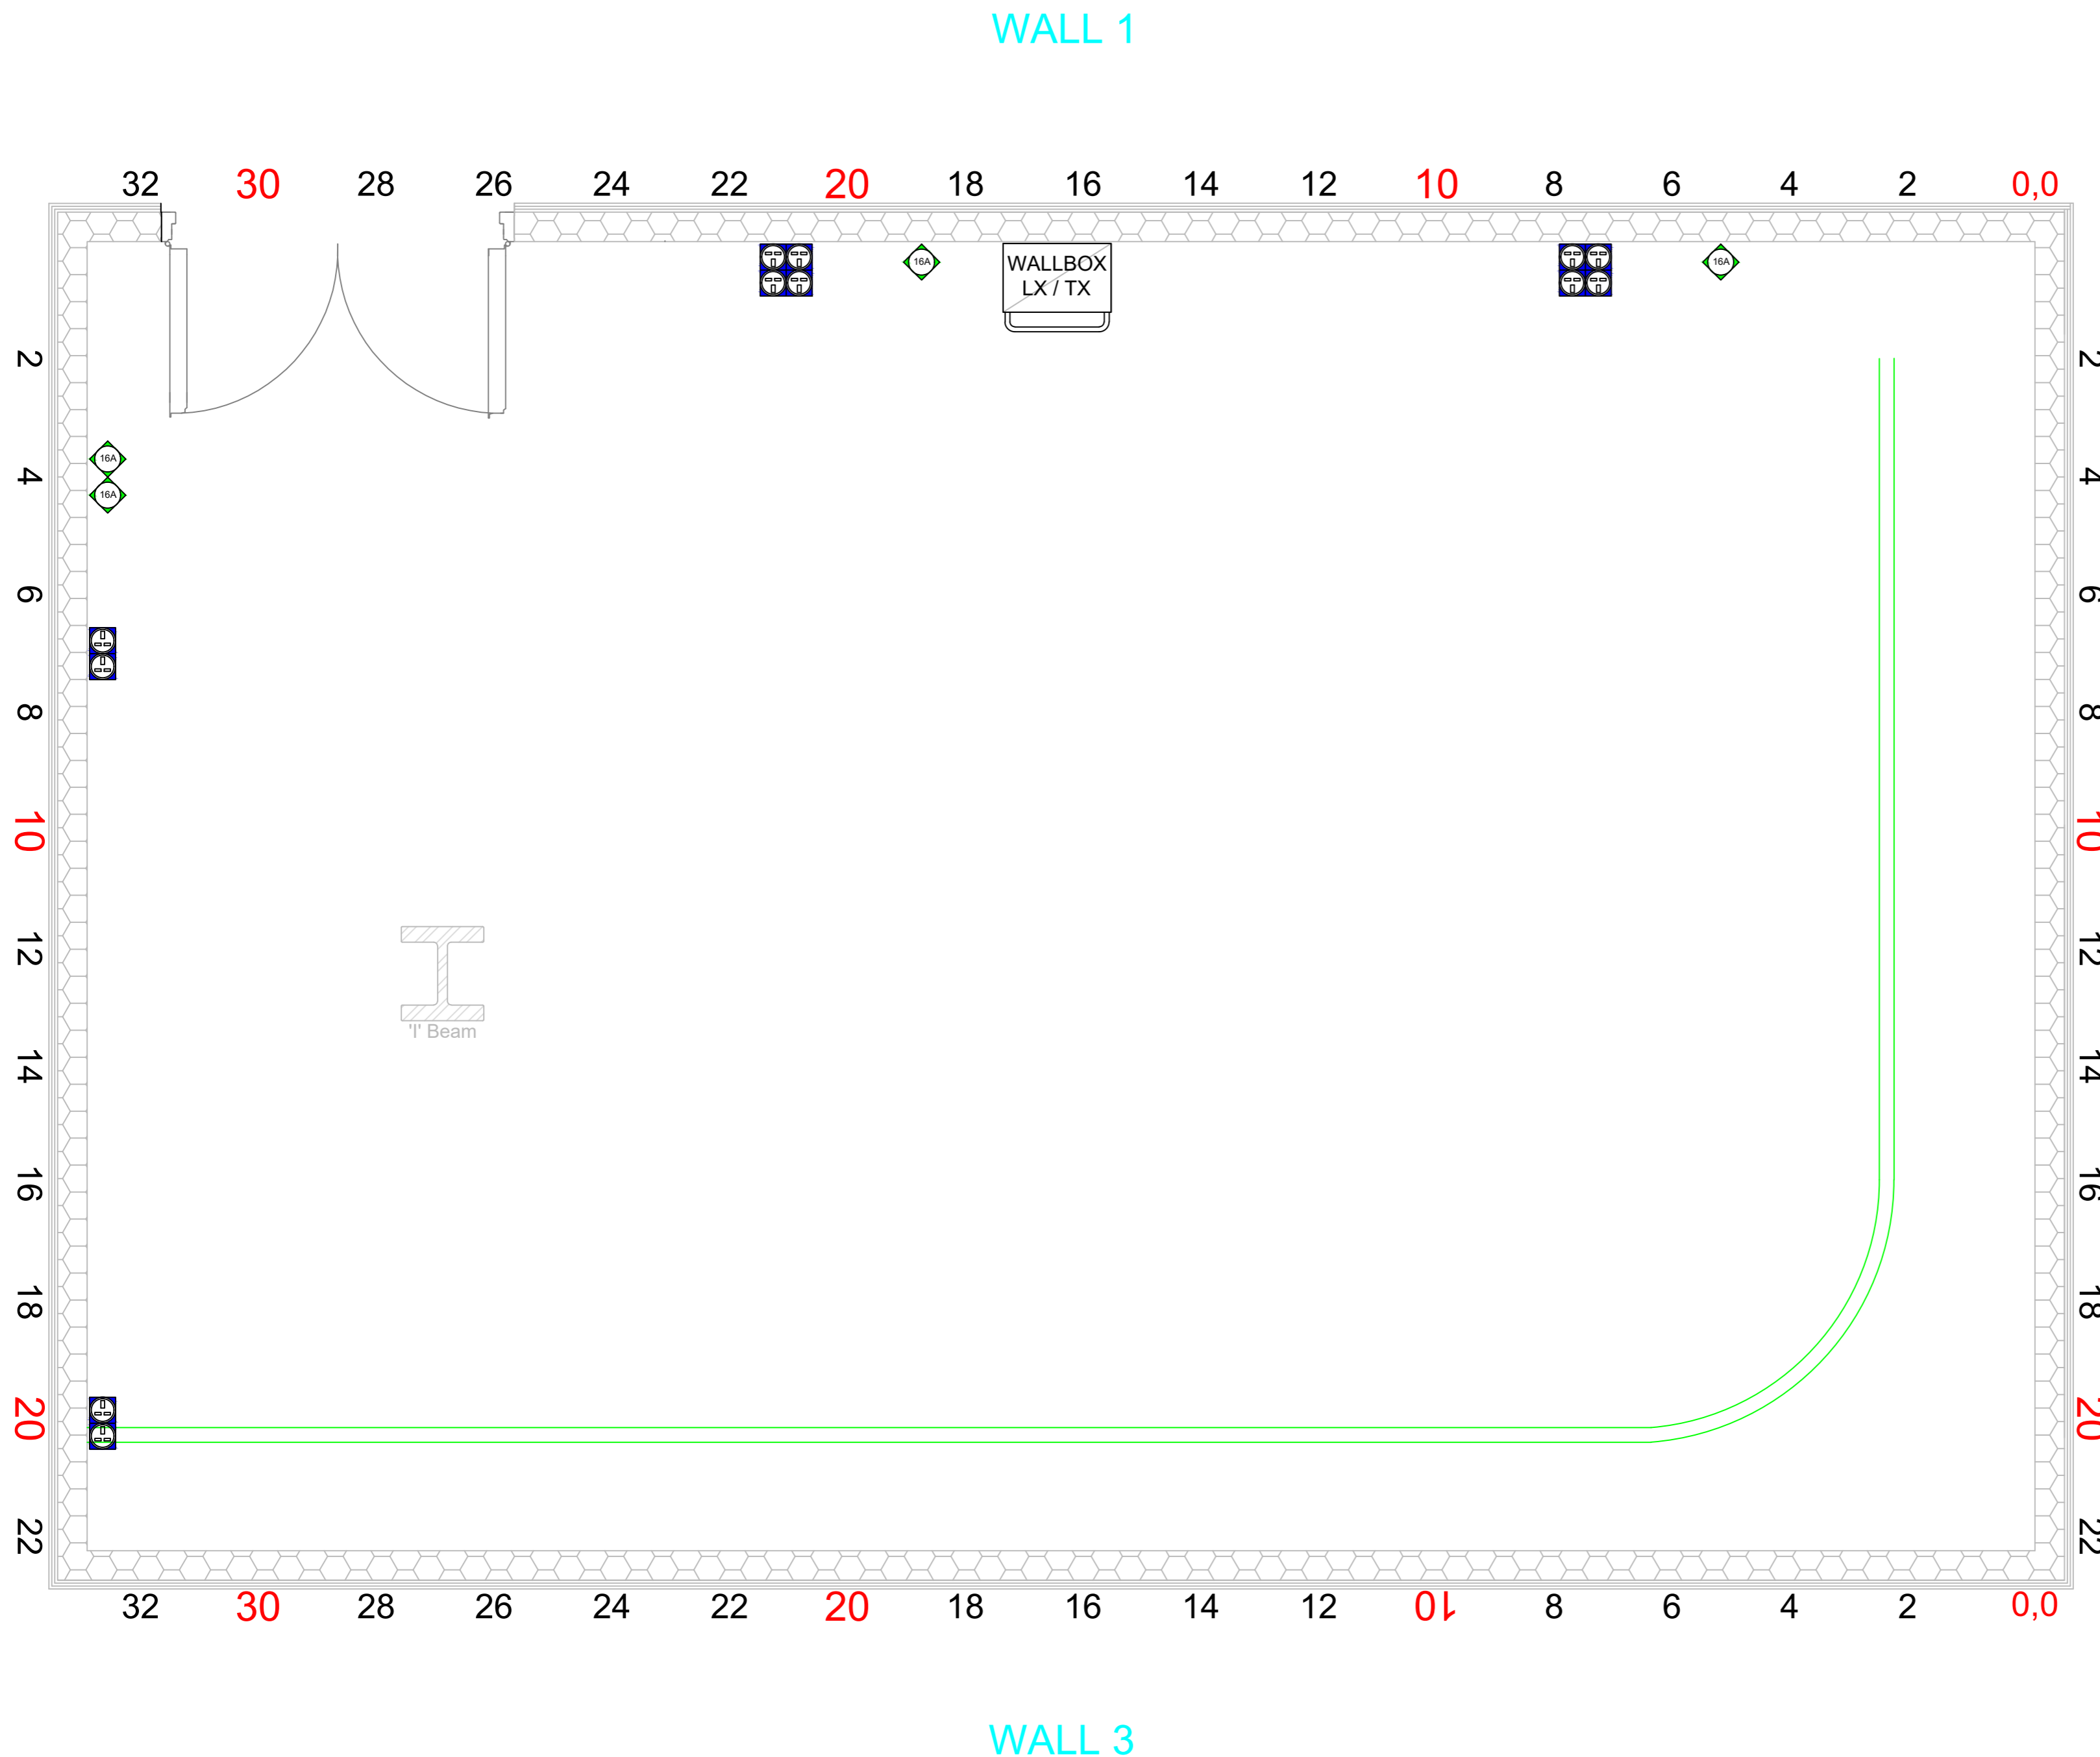


# MEDIA CITY





 
 
## HQ8 Studio Plan

### Floor Layout



- STUDIO FLOOR GRID MADE UP OF 600mm SQUARES
  - STUDIO WALL 1 TO WALL 3 6.67m
  - STUDIO WALL 2 TO WALL 4 9.92m
  - STUDIO SPACE 66.17sq m 713sq ft
  - CENTRE POINT LOAD ON ANY SCAFF TUBE 50Kg
  - NO SIDE LOADING TO THE GRID STRUCTURE AT ANY TIME
  - FLOOR IS 22mm TIMBER NOT RESIN BUT CAN BE PAINTED
  - NO LADDERS TO BE LEANT AGAINST ANY TUBE
  - HEIGHT TO CEILING IS 3.99m
  - HEIGHT TO CYC TRACK IS 3.06m
  - HEIGHT TO LIGHTING BARRELS IS 3.32m
  - 2X CYCLORAMA TRACKS CSO GREEN AND BLACKS AT 3.02m
  - SIZE OF LOAD IN DOOR: 1.8m Wide , 2.0m High
  - GROUND LEVEL MAINS:
    - 1x 32A 3φ
    - 4x 16A 1φ
    - 12x 13A 1φ
  - MAX CORRIDOR RESTRICTION W1.46m, H 2.0m
- N.B. MEASUREMENTS ARE INCLUDED AS A GUIDE. PLEASE DOUBLE CHECK ON SITE IF CRITICAL TO PRODUCTION.**

**KEY:**

- Fire Alarm Beacon** 
- Fire Alarm Sounder** 
- Cold Air Switch** 
- House Light Switch** 
- Ventilation Ducting** 
- Facility Panel** 

PRODUCTION:

DIRECTOR:

DESIGNER:

DRAWN BY:

PRODUCTION DATE:

Useful Telephone Numbers 24hr Control Room 0161 855 6400 dock10 office 0161 886 5111 MCR 0161 886 5151	<b>SCALE:</b> 1:25 @ ISO_A2_(420_X_594_MM)
Version: v2 Drafted 06/10/2026, TK	

Unauthorised copying or distribution is prohibited

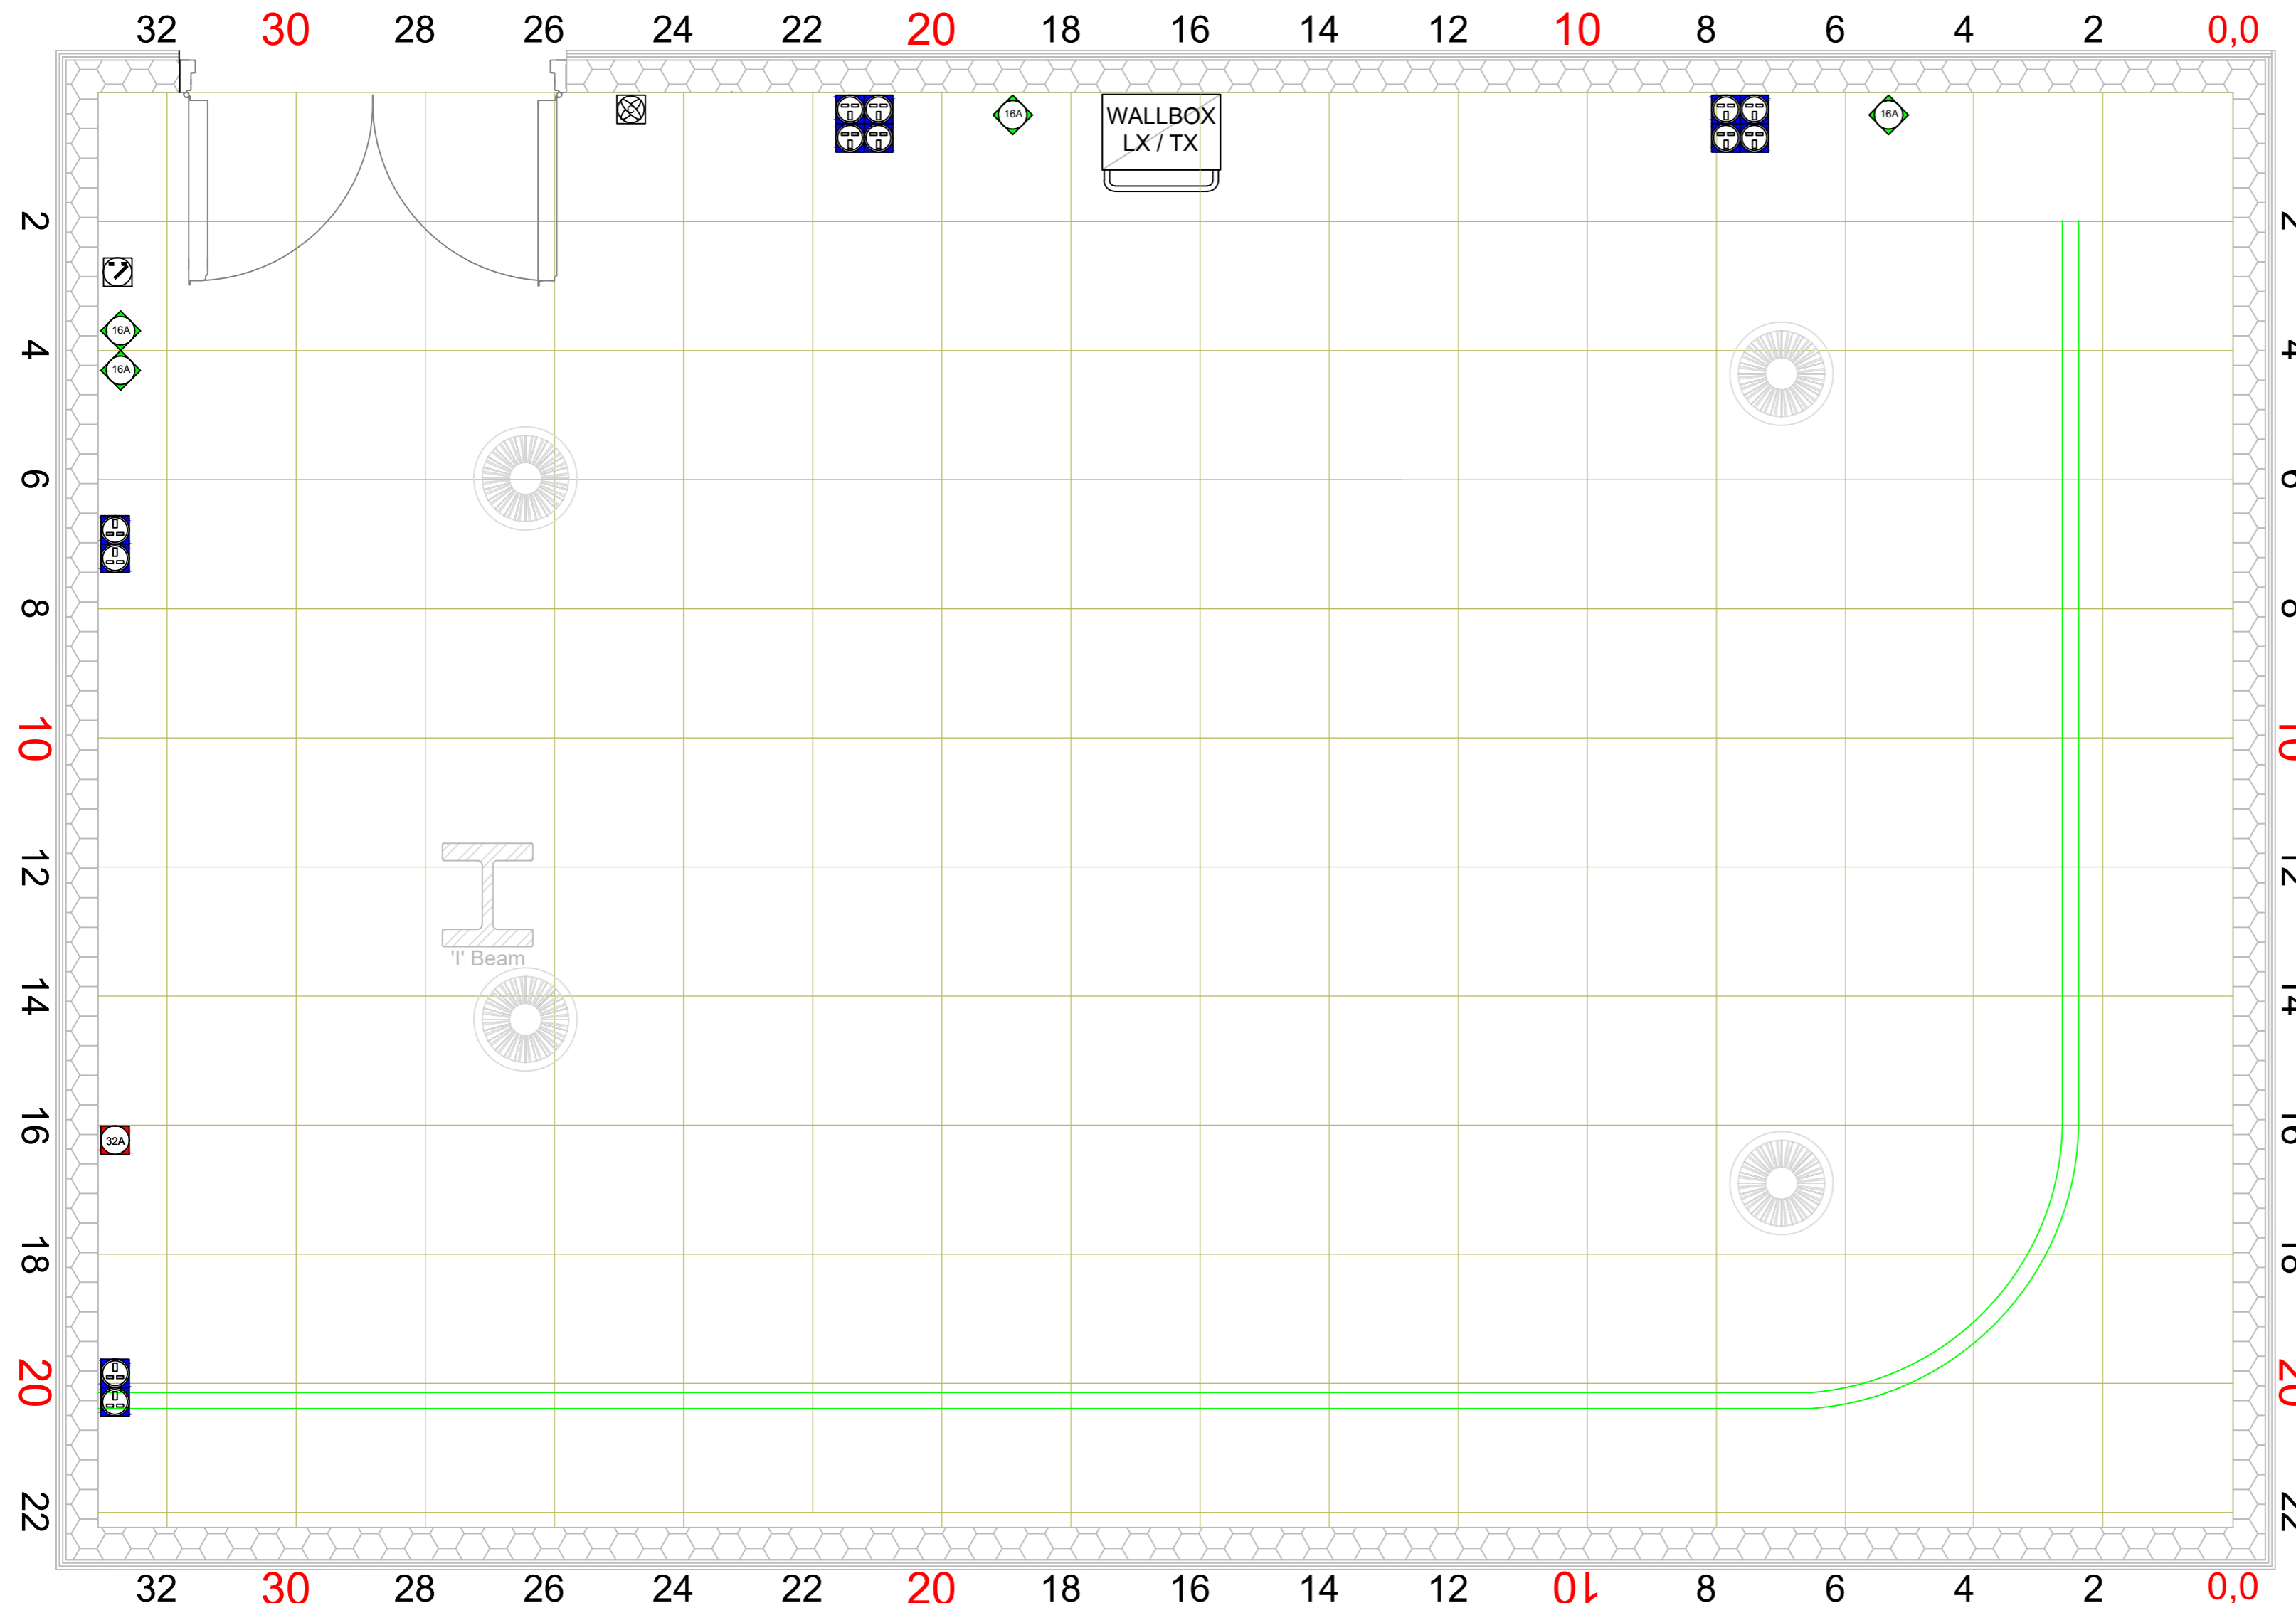
# MEDIA CITY

## HQ8 Studio Plan

### Setting Layout

WALL 1

WALL 3



- STUDIO FLOOR GRID MADE UP OF 600mm SQUARES

- STUDIO WALL 1 TO WALL 3 6.67m  
 - STUDIO WALL 2 TO WALL 4 9.92m  
 - STUDIO SPACE 66.17sq m 713sq ft  
 - CENTRE POINT LOAD ON ANY SCAFF TUBE 50Kg  
 - NO SIDE LOADING TO THE GRID STRUCTURE AT ANY TIME  
 - FLOOR IS 22mm TIMBER NOT RESIN BUT CAN BE PAINTED

- NO LADDERS TO BE LEANT AGAINST ANY TUBE

- HEIGHT TO CEILING IS 3.99m  
 - HEIGHT TO CYC TRACK IS 3.06m  
 - HEIGHT TO LIGHTING BARRELS IS 3.32m

- 2X CYCLOPAMA TRACKS CSO GREEN AND BLACKS AT 3.02m

- SIZE OF LOAD IN DOOR: 1.8m Wide , 2.0m High

- GROUND LEVEL MAINS:  
 1x 32A 3φ  
 4x 16A 1φ  
 12x 13A 1φ

- MAX CORRIDOR RESTRICTION W1.46m, H 2.0m

**N.B. MEASUREMENTS ARE INCLUDED AS A GUIDE. PLEASE DOUBLE CHECK ON SITE IF CRITICAL TO PRODUCTION.**

#### KEY:

**Fire Alarm Beacon**

**Fire Alarm Sounder**

**Cold Air Switch**



**House Light Switch**



**Ventilation Ducting**



**Facility Panel**



PRODUCTION:

DIRECTOR:

DESIGNER:

DRAWN BY:

PRODUCTION DATE:

Useful Telephone Numbers  
 24hr Control Room 0161 855 6400  
 dock10 office 0161 886 5111  
 MCR 0161 886 5151

**SCALE:**  
 1:25 @  
 ISO\_A2\_(420\_X\_594\_MM)

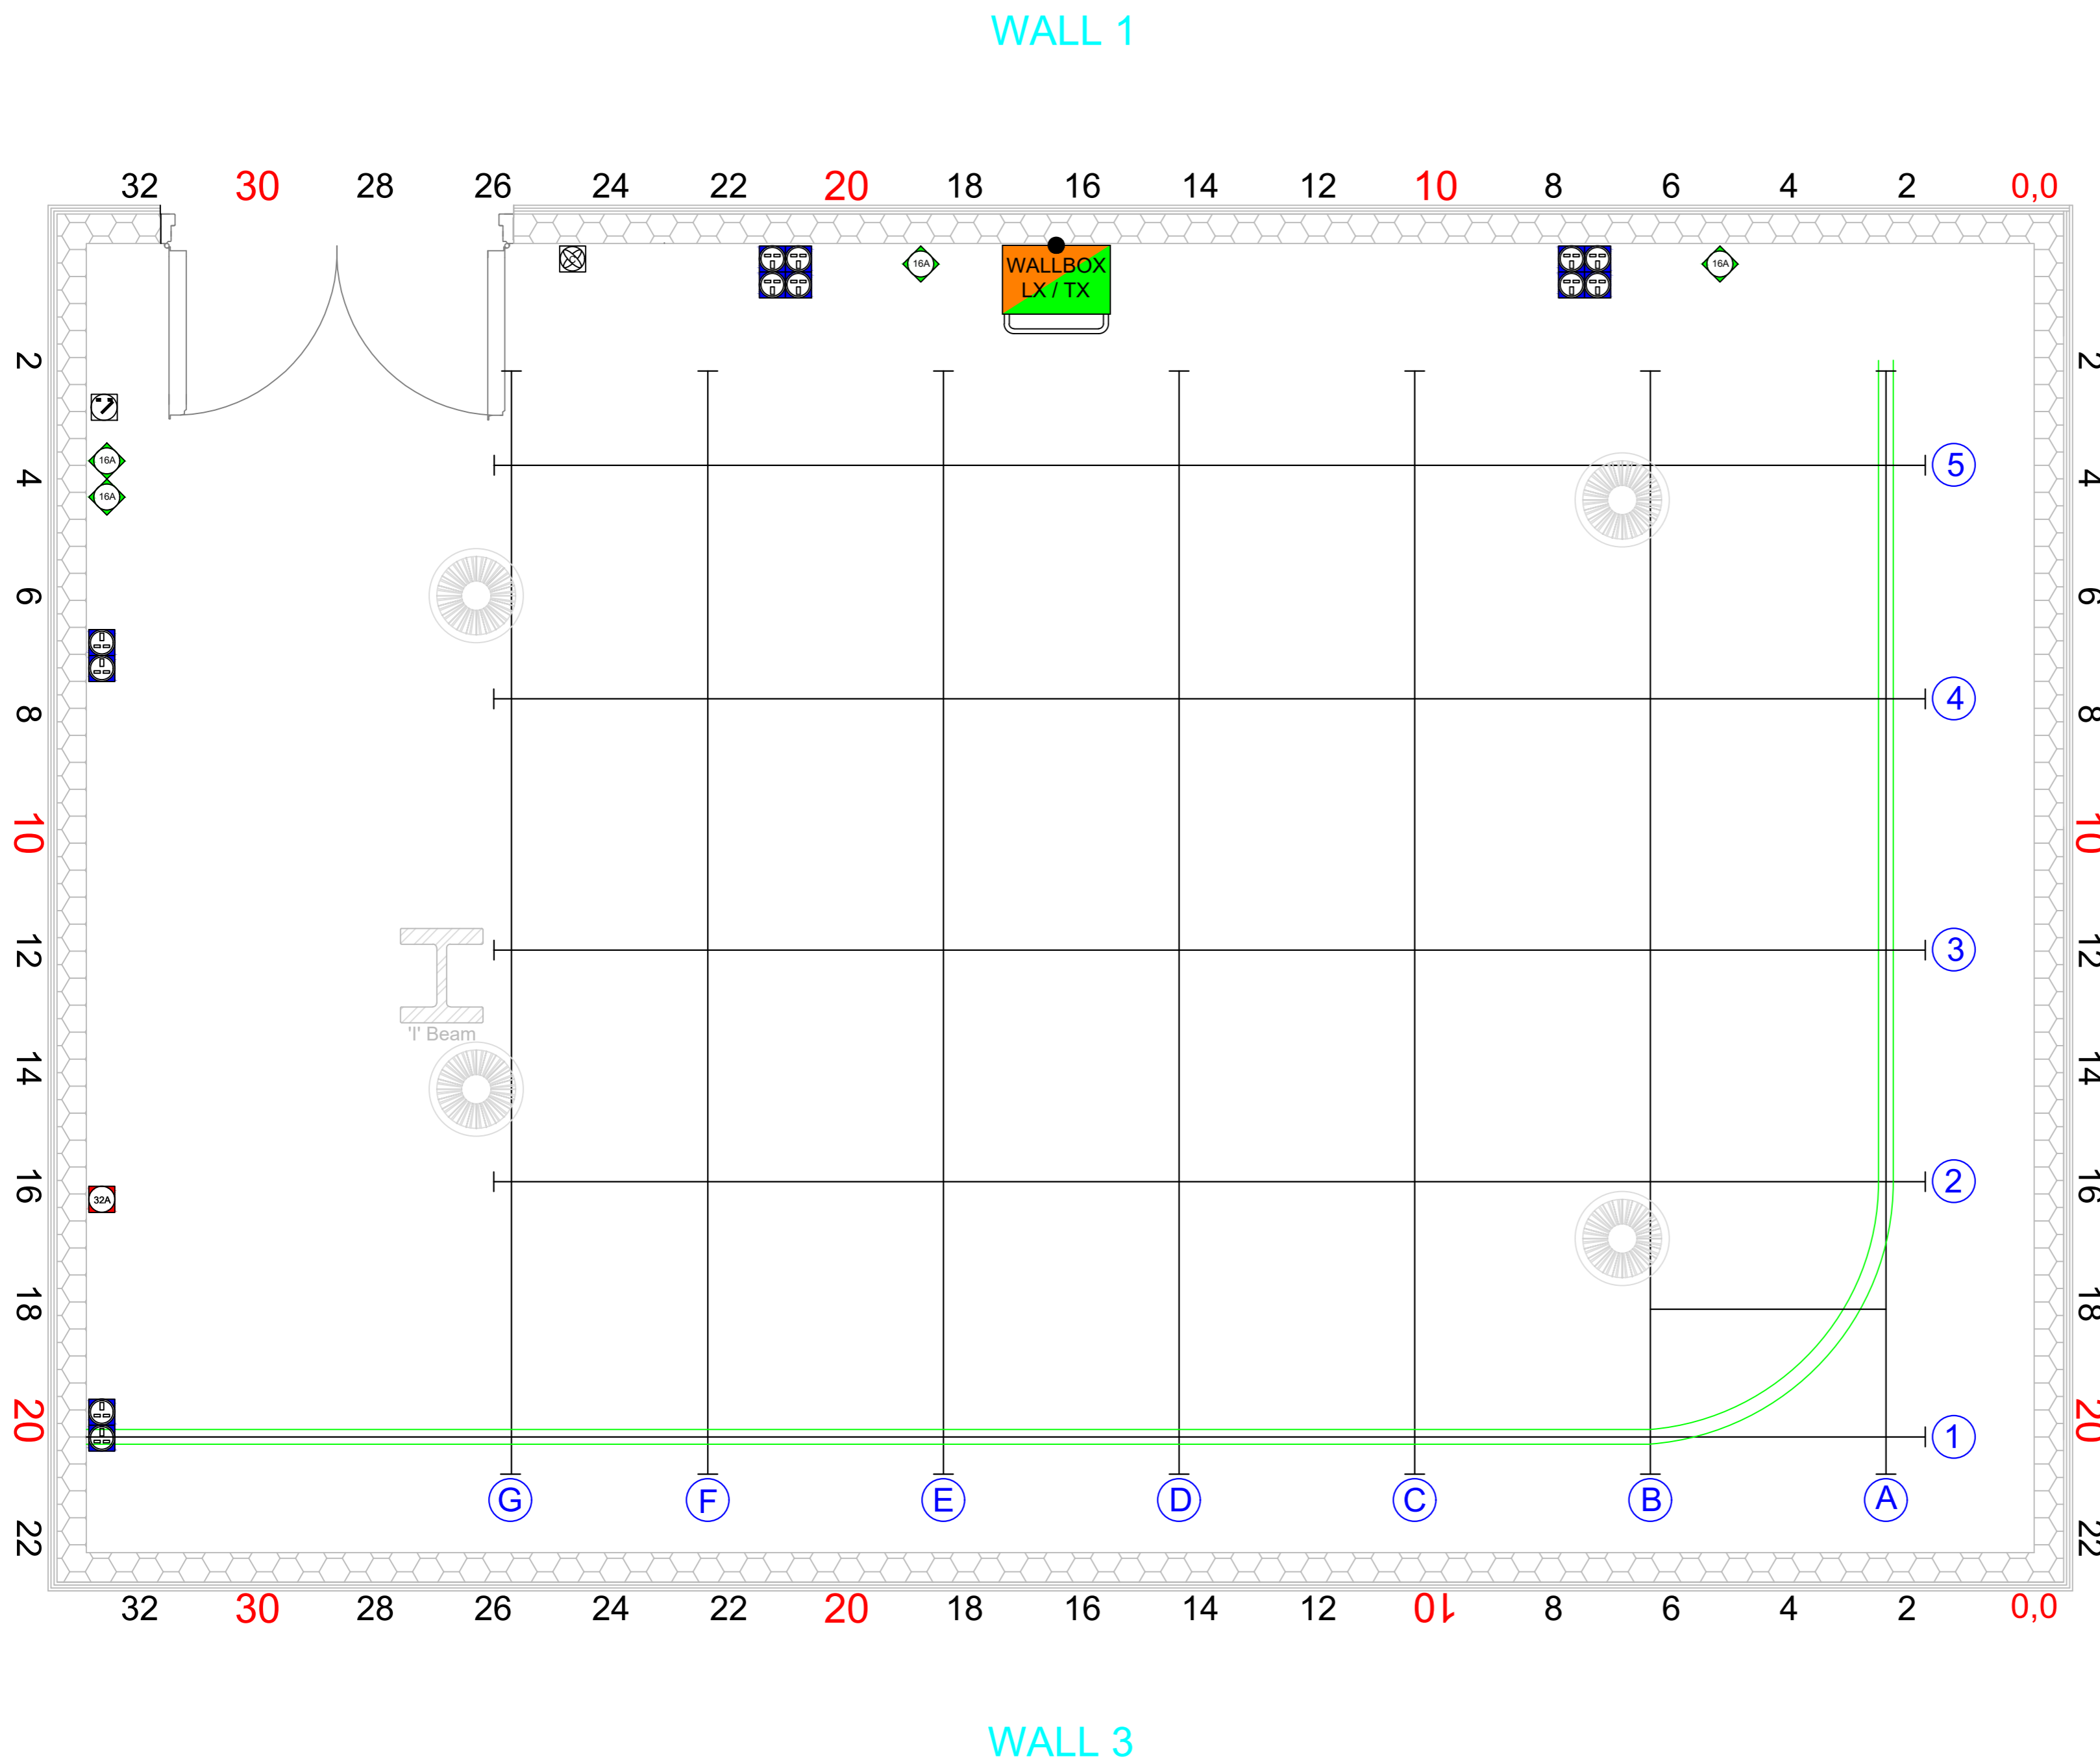
Unauthorised copying or distribution is prohibited

**Version:**  
 Drafted 06/10/2026, TK

# MEDIA CITY




 
## HQ8 Studio Plan

### Lighting Director's Plan



- STUDIO FLOOR GRID MADE UP OF 600mm SQUARES
- STUDIO WALL 1 TO WALL 3 6.67m
- STUDIO WALL 2 TO WALL 4 9.92m
- STUDIO SPACE 66.17sq m 713sq ft
- CENTRE POINT LOAD ON ANY SCAFF TUBE 50Kg
- NO SIDE LOADING TO THE GRID STRUCTURE AT ANY TIME
- FLOOR IS 22mm TIMBER NOT RESIN BUT CAN BE PAINTED
- NO LADDERS TO BE LEANT AGAINST ANY TUBE
- HEIGHT TO CEILING IS 3.99m
- HEIGHT TO CYC TRACK IS 3.06m
- HEIGHT TO LIGHTING BARRELS IS 3.32m
- 2X CYCLORAMA TRACKS CSO GREEN AND BLACKS AT 3.02m
- SIZE OF LOAD IN DOOR: 1.8m Wide , 2.0m High
- GROUND LEVEL MAINS:
  - 1x 32A 3φ
  - 4x 16A 1φ
  - 12x 13A 1φ
- MAX CORRIDOR RESTRICTION W1.46m, H 2.0m
- N.B. MEASUREMENTS ARE INCLUDED AS A GUIDE. PLEASE DOUBLE CHECK ON SITE IF CRITICAL TO PRODUCTION.**

#### KEY:

- Fire Alarm Beacon**
- Fire Alarm Sounder**
- Cold Air Switch** 
- House Light Switch** 
- Ventilation Ducting** 
- Facility Panel** 

PRODUCTION:

DIRECTOR:

DESIGNER:

DRAWN BY:

PRODUCTION DATE:

Useful Telephone Numbers  
 24hr Control Room 0161 855 6400  
 dock10 office 0161 886 5111  
 MCR 0161 886 5151

**SCALE:**  
 1:25 @  
 ISO\_A2\_(420\_X\_594\_MM)

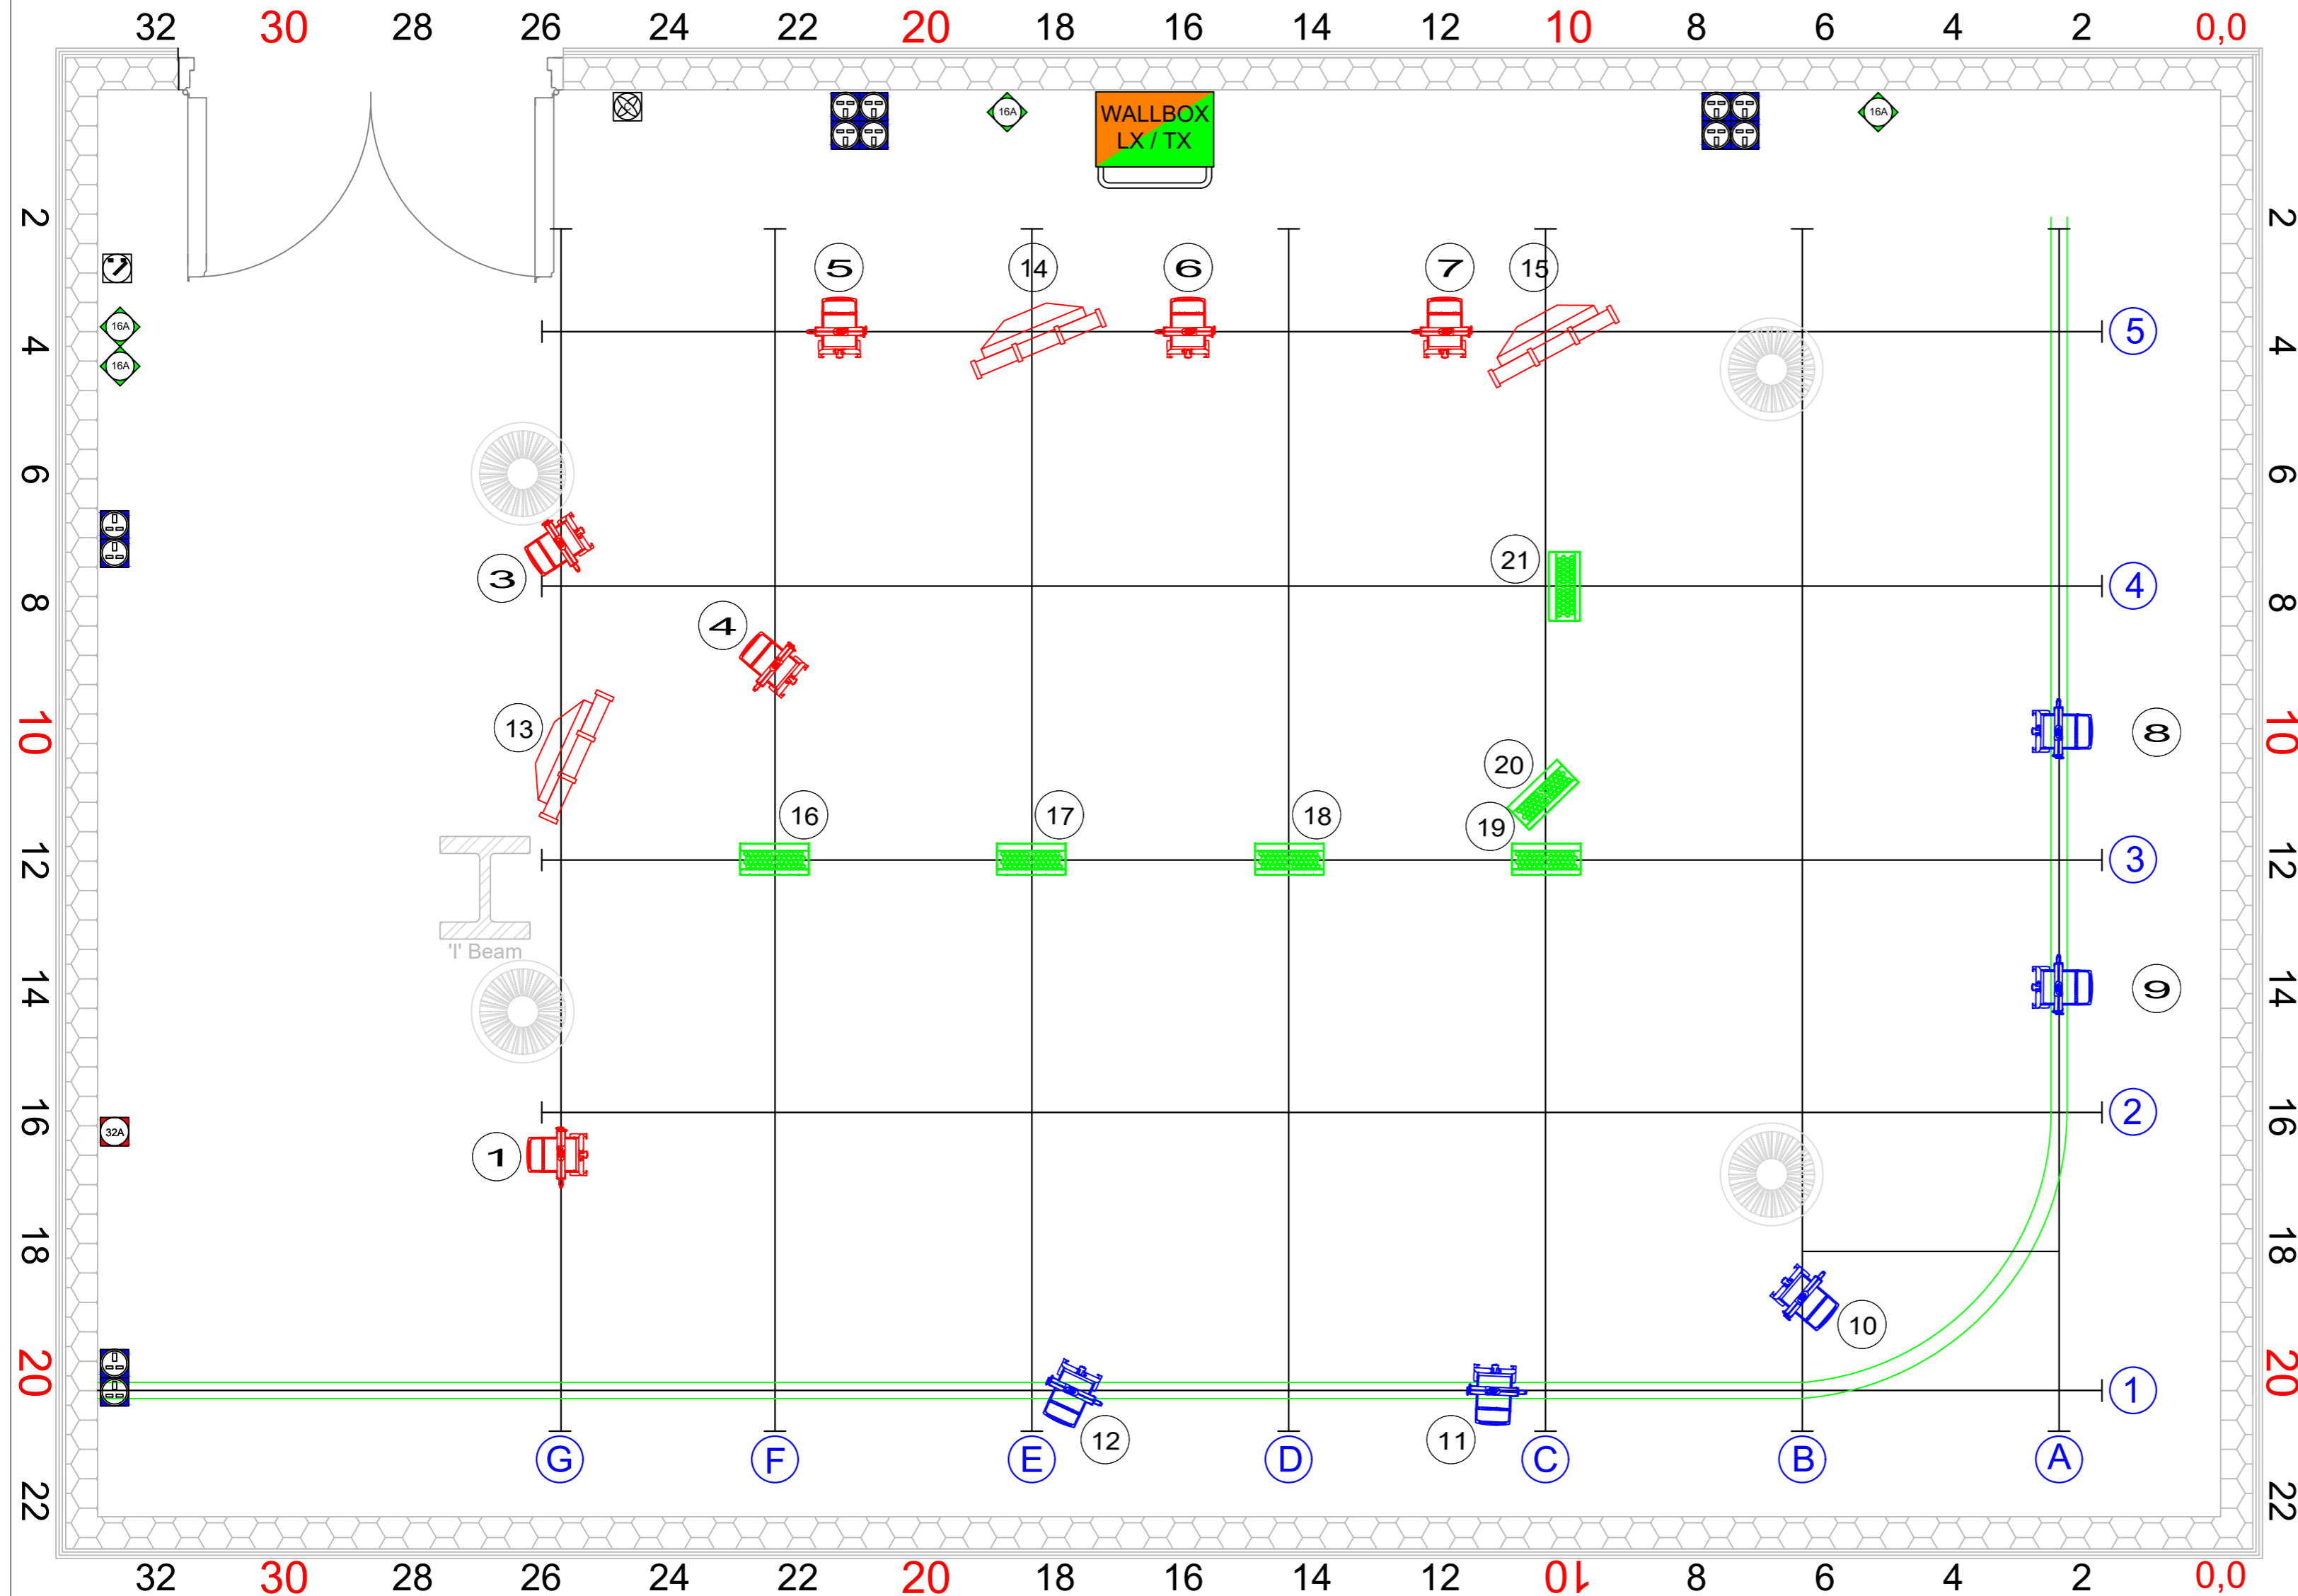
Unauthorised copying or distribution is prohibited

**Version:**  
 Drafted 06/10/2026, TK

# MEDIA CITY

## HQ8 Studio Plan

### Generic Lighting Plan



- STUDIO FLOOR GRID MADE UP OF 600mm SQUARES
- STUDIO WALL 1 TO WALL 3 6.67m
- STUDIO WALL 2 TO WALL 4 9.92m
- STUDIO SPACE 66.17sq m 713sq ft
- CENTRE POINT LOAD ON ANY SCAFF TUBE 50Kg
- NO SIDE LOADING TO THE GRID STRUCTURE AT ANY TIME
- FLOOR IS 22mm TIMBER NOT RESIN BUT CAN BE PAINTED
- NO LADDERS TO BE LEANT AGAINST ANY TUBE
- HEIGHT TO CEILING IS 3.99m
- HEIGHT TO CYC TRACK IS 3.06m
- HEIGHT TO LIGHTING BARRELS IS 3.32m
- 2X CYCLORAMA TRACKS CSO GREEN AND BLACKS AT 3.02m
- SIZE OF LOAD IN DOOR: 1.8m Wide , 2.0m High
- GROUND LEVEL MAINS:
  - 1x 32A 3φ
  - 4x 16A 1φ
  - 12x 13A 1φ
- MAX CORRIDOR RESTRICTION W1.46m, H 2.0m
- N.B. MEASUREMENTS ARE INCLUDED AS A GUIDE. PLEASE DOUBLE CHECK ON SITE IF CRITICAL TO PRODUCTION.**

**KEY:**

- Fire Alarm Beacon**
- Fire Alarm Sounder**
- Cold Air Switch**
- House Light Switch**
- Ventilation Ducting**
- Facility Panel**

PRODUCTION:

DIRECTOR:

DESIGNER:

DRAWN BY:

PRODUCTION DATE:

Useful Telephone Numbers

24hr Control Room 0161 855 6400  
 dock10 office 0161 886 5111  
 MCR 0161 886 5151

**SCALE:**  
 1:25 @  
 ISO\_A2\_(420\_X\_594\_MM)

Unauthorised copying or distribution is prohibited

**Version:**  
 Drafted 06/10/2026, TK

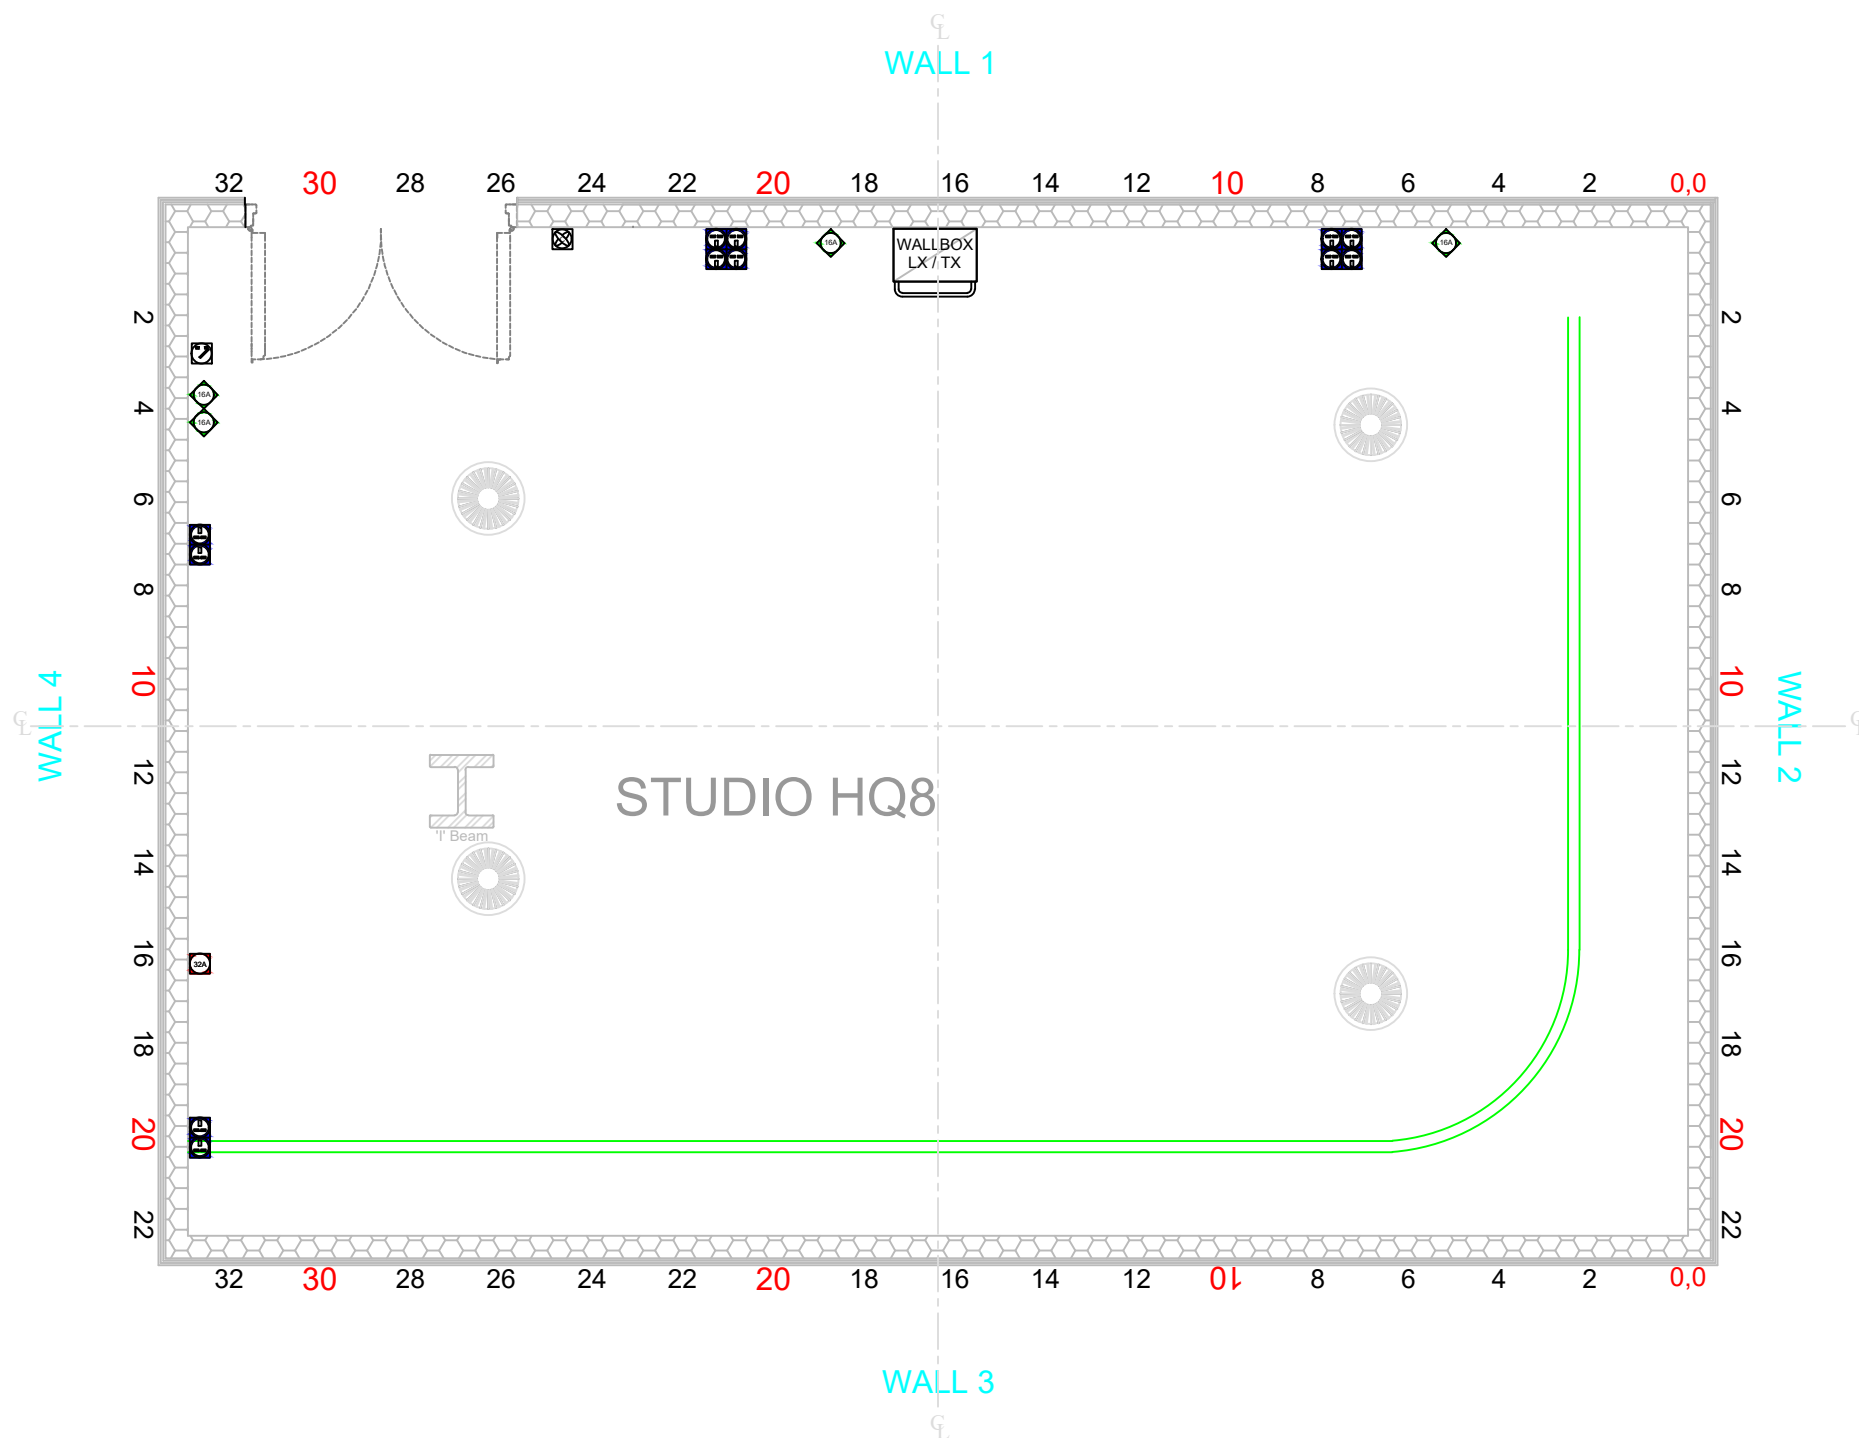
**Fixture Key**

- Chroma-Q Studio Force T 12 Phosphor
- Prolights Evo160F (Mode STD.P-5 channel with 1/4 CTO (206)
- Prolights Evo160F (Mode STD.P-5 channel with 1/2 Diff (250)
- Chroma-Q Space Force (2 Channel Mode)

# MEDIA CITY

## HQ8 Studio Plan

### HQ8 Floor Layout



- STUDIO FLOOR GRID MADE UP OF 600mm SQUARES

- STUDIO WALL 1 TO WALL 3 6.67m
- STUDIO WALL 2 TO WALL 4 9.92m
- STUDIO SPACE 66.17sq m 713sq ft
- CENTRE POINT LOAD ON ANY SCAFF TUBE 50Kg
- NO SIDE LOADING TO THE GRID STRUCTURE AT ANY TIME
- NO LADDERS TO BE LEANT AGAINST ANY TUBE
- FLOOR IS 22mm TIMBER NOT RESIN BUT CAN BE PAINTED

- HEIGHT TO CEILING IS 3.99m
- HEIGHT TO CYC TRACK IS 3.06m
- HEIGHT TO LIGHTING BARRELS IS 3.32m

- 2X CYCLORAMA TRACKS CSO GREEN AND BLACKS AT 3.02m

- SIZE OF LOAD IN DOOR: 1.8m Wide , 2.0m High





- GROUND LEVEL MAINS:

- 1x 32A 3φ
- 4x 16A 1φ
- 12x 13A 1φ

- MAX CORRIDOR RESTRICTION W1.46m, H 2.0m

**N.B. MEASUREMENTS ARE INCLUDED AS A GUIDE. PLEASE DOUBLE CHECK ON SITE IF CRITICAL TO PRODUCTION.**

#### KEY:

- Fire Alarm Beacon**
- Fire Alarm Sounder**
- Cold Air Switch** 
- House Light Switch** 
- Ventilation Ducting** 
- Facility Panel** 

PRODUCTION:

DIRECTOR:

DESIGNER:

DRAWN BY:

PRODUCTION DATE:

Useful Telephone Numbers  
 24hr Control Room 0161 855 6400  
 dock10 office 0161 886 5111  
 MCR 0161 886 5151

**SCALE:**  
 1:50 @  
 ISO\_A3\_(420\_X\_297\_MM)

Unauthorised copying or distribution is prohibited

**Version:**  
 Drafted 06/10/2026,

# MEDIA CITY

## HQ8 Studio Plan

### HQ8 Sedtting Layout

- STUDIO FLOOR GRID MADE UP OF 600mm SQUARES

- STUDIO WALL 1 TO WALL 3 6.67m
- STUDIO WALL 2 TO WALL 4 9.92m
- STUDIO SPACE 66.17sq m 713sq ft
- CENTRE POINT LOAD ON ANY SCAFF TUBE 50Kg
- NO SIDE LOADING TO THE GRID STRUCTURE AT ANY TIME
- NO LADDERS TO BE LEANT AGAINST ANY TUBE
- FLOOR IS 22mm TIMBER NOT RESIN BUT CAN BE PAINTED

- HEIGHT TO CEILING IS 3.99m
- HEIGHT TO CYC TRACK IS 3.06m
- HEIGHT TO LIGHTING BARRELS IS 3.32m

- 2X CYCLORAMA TRACKS CSO GREEN AND BLACKS AT 3.02m

- SIZE OF LOAD IN DOOR: 1.8m Wide , 2.0m High

- GROUND LEVEL MAINS:

- 1x 32A 3φ
- 4x 16A 1φ
- 12x 13A 1φ

- MAX CORRIDOR RESTRICTION W1.46m, H 2.0m

**N.B. MEASUREMENTS ARE INCLUDED AS A GUIDE. PLEASE DOUBLE CHECK ON SITE IF CRITICAL TO PRODUCTION.**

#### KEY:

**Fire Alarm Beacon**

**Fire Alarm Sounder**

**Cold Air Switch**



**House Light Switch**



**Ventilation Ducting**



**Facility Panel**



PRODUCTION:

DIRECTOR:

DESIGNER:

DRAWN BY:

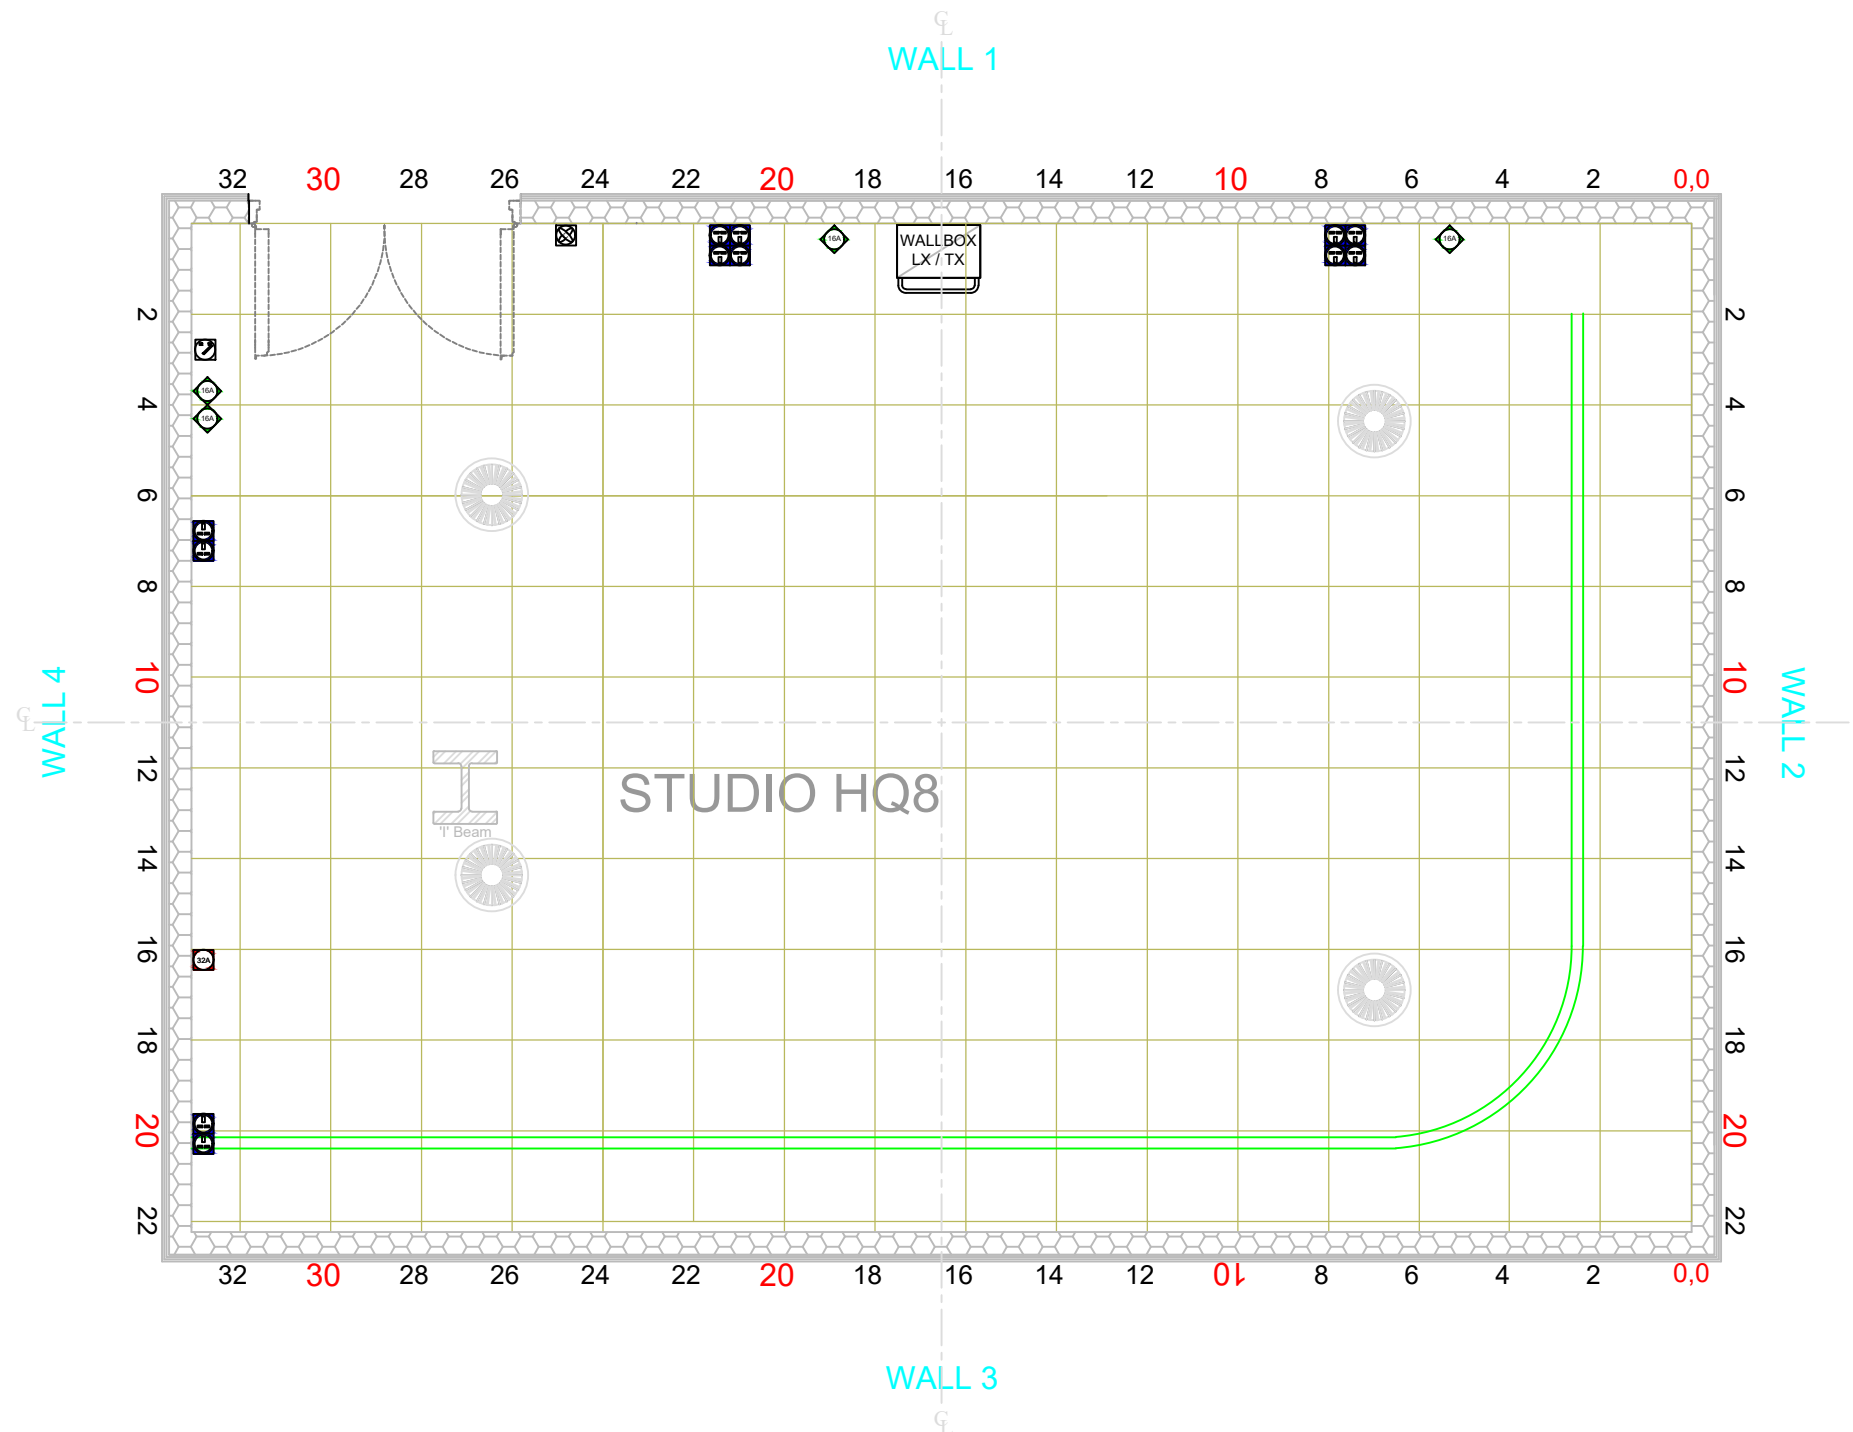
PRODUCTION DATE:

Useful Telephone Numbers  
 24hr Control Room 0161 855 6400  
 dock10 office 0161 886 5111  
 MCR 0161 886 5151

**SCALE:**  
 1:50 @  
 ISO\_A3\_(420\_X\_297\_MM)

Unauthorised copying or distribution is prohibited

**Version:**  
 Drafted 06/10/2026,



# MEDIA CITY







## HQ8 Studio Plan

### Lighting Director's Plan

- STUDIO FLOOR GRID MADE UP OF 600mm SQUARES
- STUDIO WALL 1 TO WALL 3 6.67m
- STUDIO WALL 2 TO WALL 4 9.92m
- STUDIO SPACE 66.17sq m 713sq ft
- CENTRE POINT LOAD ON ANY SCAFF TUBE 50Kg
- NO SIDE LOADING TO THE GRID STRUCTURE AT ANY TIME
- NO LADDERS TO BE LEANT AGAINST ANY TUBE
- FLOOR IS 22mm TIMBER NOT RESIN BUT CAN BE PAINTED
- HEIGHT TO CEILING IS 3.99m
- HEIGHT TO CYC TRACK IS 3.06m
- HEIGHT TO LIGHTING BARRELS IS 3.32m
- 2X CYCLORAMA TRACKS CSO GREEN AND BLACKS AT 3.02m
- SIZE OF LOAD IN DOOR: 1.8m Wide , 2.0m High
- GROUND LEVEL MAINS:
  - 1x 32A 3φ
  - 4x 16A 1φ
  - 12x 13A 1φ
- MAX CORRIDOR RESTRICTION W1.46m, H 2.0m

**N.B. MEASUREMENTS ARE INCLUDED AS A GUIDE. PLEASE DOUBLE CHECK ON SITE IF CRITICAL TO PRODUCTION.**

#### KEY:

- Fire Alarm Beacon** 
- Fire Alarm Sounder** 
- Cold Air Switch** 
- House Light Switch** 
- Ventilation Ducting** 
- Facility Panel** 

PRODUCTION:

DIRECTOR:

DESIGNER:

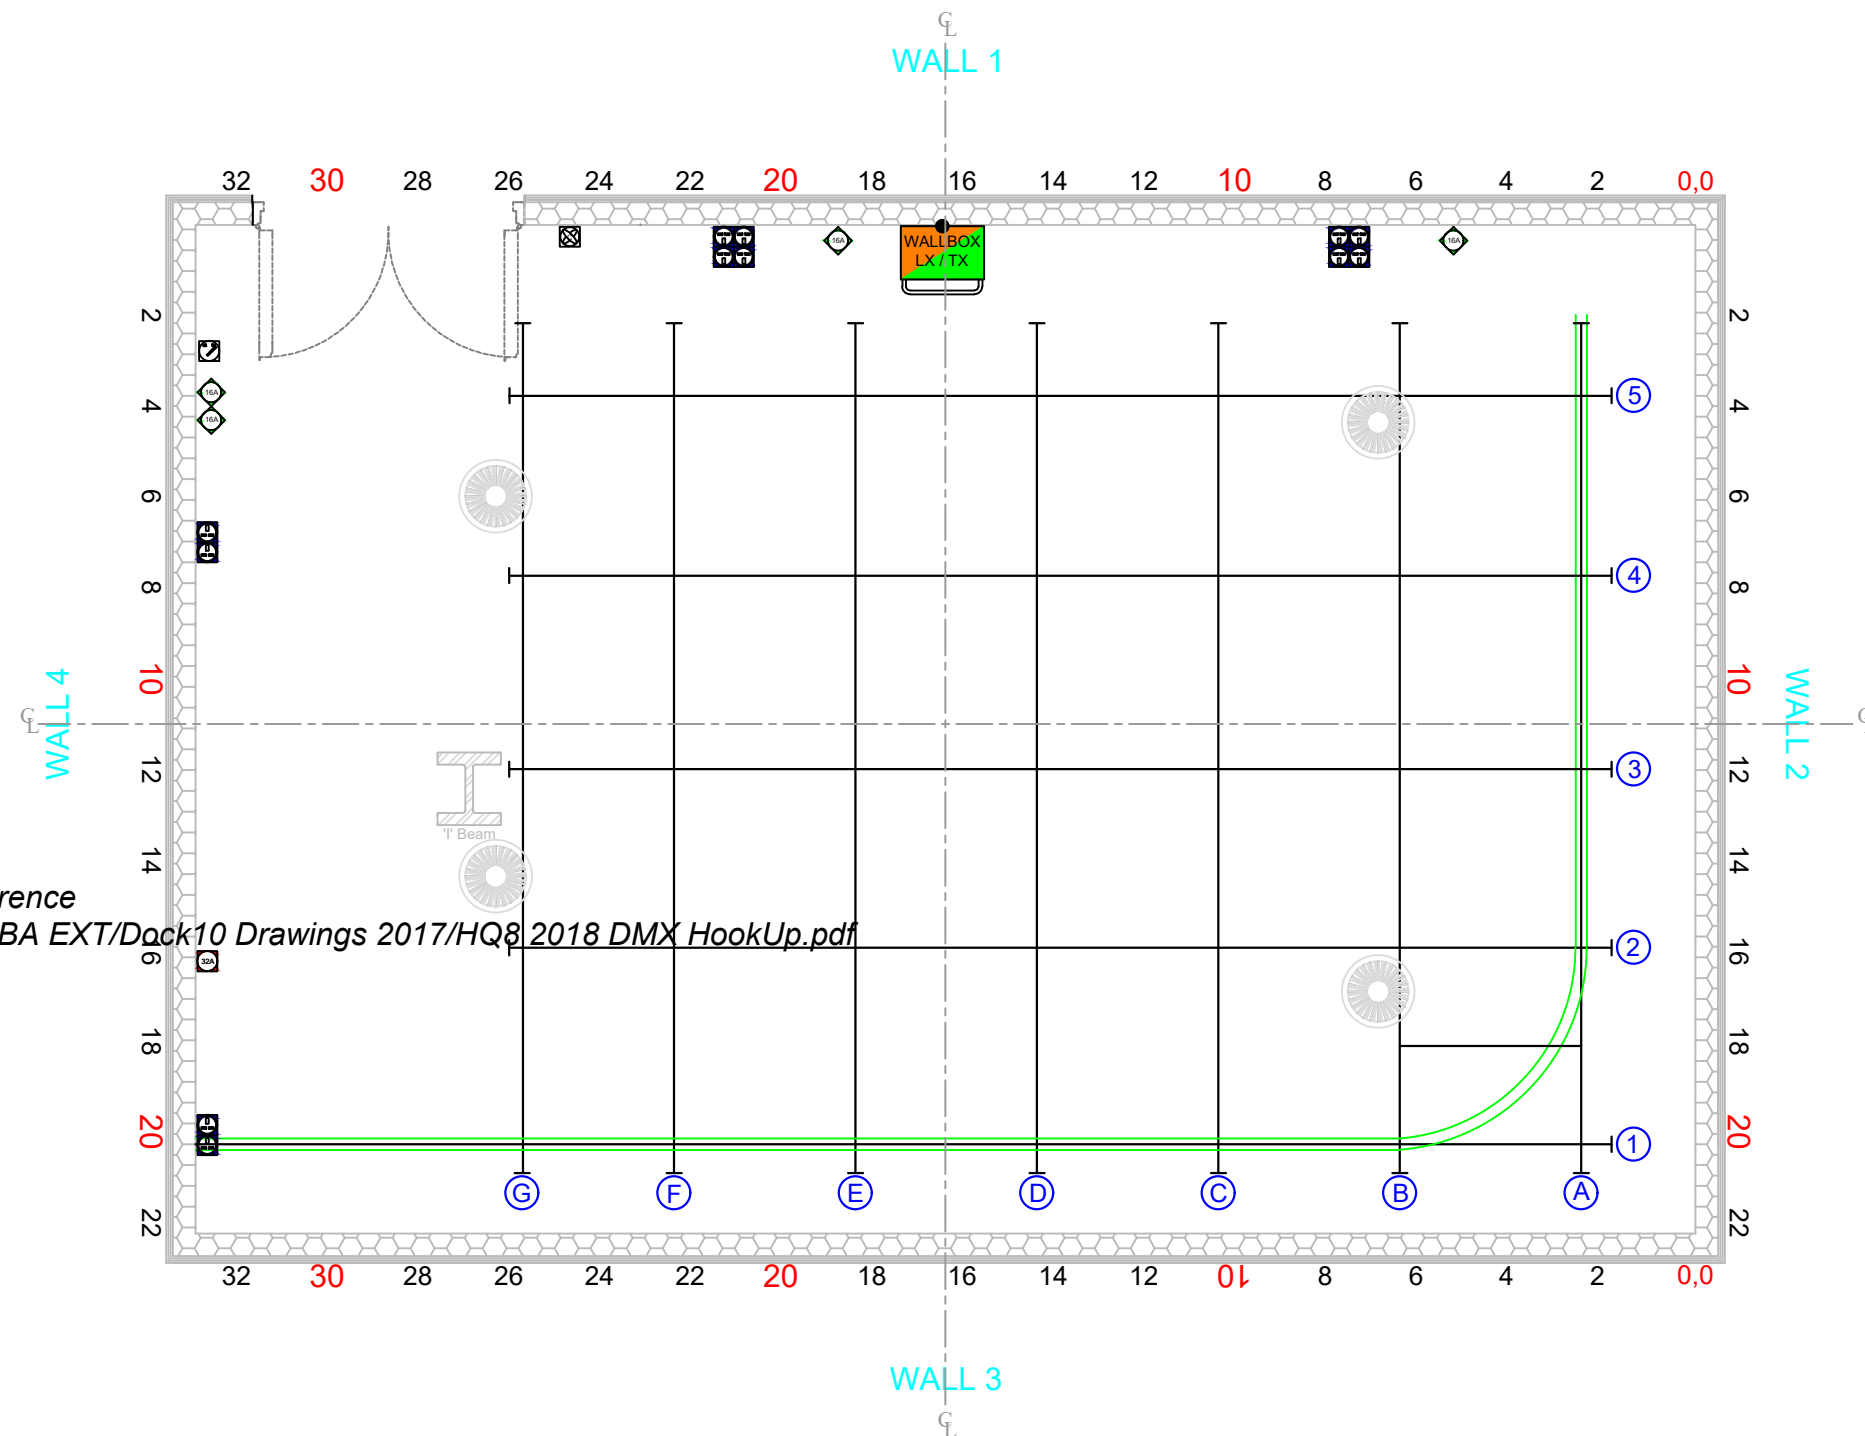
DRAWN BY:

PRODUCTION DATE:

Useful Telephone Numbers  
 24hr Control Room 0161 855 6400  
 dock10 office 0161 886 5111  
 MCR 0161 886 5151

 



**SCALE:**  
 1:50 @  
 ISO\_A3\_(420\_X\_297\_MM)

**Version:**  
 Drafted 06/10/2026,



Missing or invalid reference  
 File: /Volumes/TOSHIBA EXT/Dock10 Drawings 2017/HQ8 2018 DMX HookUp.pdf  
 Sheet: 1

#### Fixture Key

- Chroma-Q Studio Force T 12 Phosphor** 
- Prolights Evo160F (Mode STD.P-5 channel with 1/4 CTO (206))** 
- Prolights Evo160F (Mode STD.P-5 channel with 1/2 Diff (250))** 
- Chroma-Q Space Force (2 Channel Mode)** 

# MEDIA CITY

## HQ8 Studio Plan







### Generic Lighting Layout

- STUDIO FLOOR GRID MADE UP OF 600mm SQUARES
- STUDIO WALL 1 TO WALL 3 6.67m
- STUDIO WALL 2 TO WALL 4 9.92m
- STUDIO SPACE 66.17sq m 713sq ft
- CENTRE POINT LOAD ON ANY SCAFF TUBE 50Kg
- NO SIDE LOADING TO THE GRID STRUCTURE AT ANY TIME
- FLOOR IS 22mm TIMBER NOT RESIN BUT CAN BE PAINTED
- NO LADDERS TO BE LEANT AGAINST ANY TUBE
- HEIGHT TO CEILING IS 3.99m
- HEIGHT TO CYC TRACK IS 3.06m
- HEIGHT TO LIGHTING BARRELS IS 3.32m
- 2X CYCLOTRAMA TRACKS CSO GREEN AND BLACKS AT 3.02m
- SIZE OF LOAD IN DOOR: 1.8m Wide , 2.0m High
- GROUND LEVEL MAINS:
  - 1x 32A 3φ
  - 4x 16A 1φ
  - 12x 13A 1φ

- MAX CORRIDOR RESTRICTION W1.46m, H 2.0m

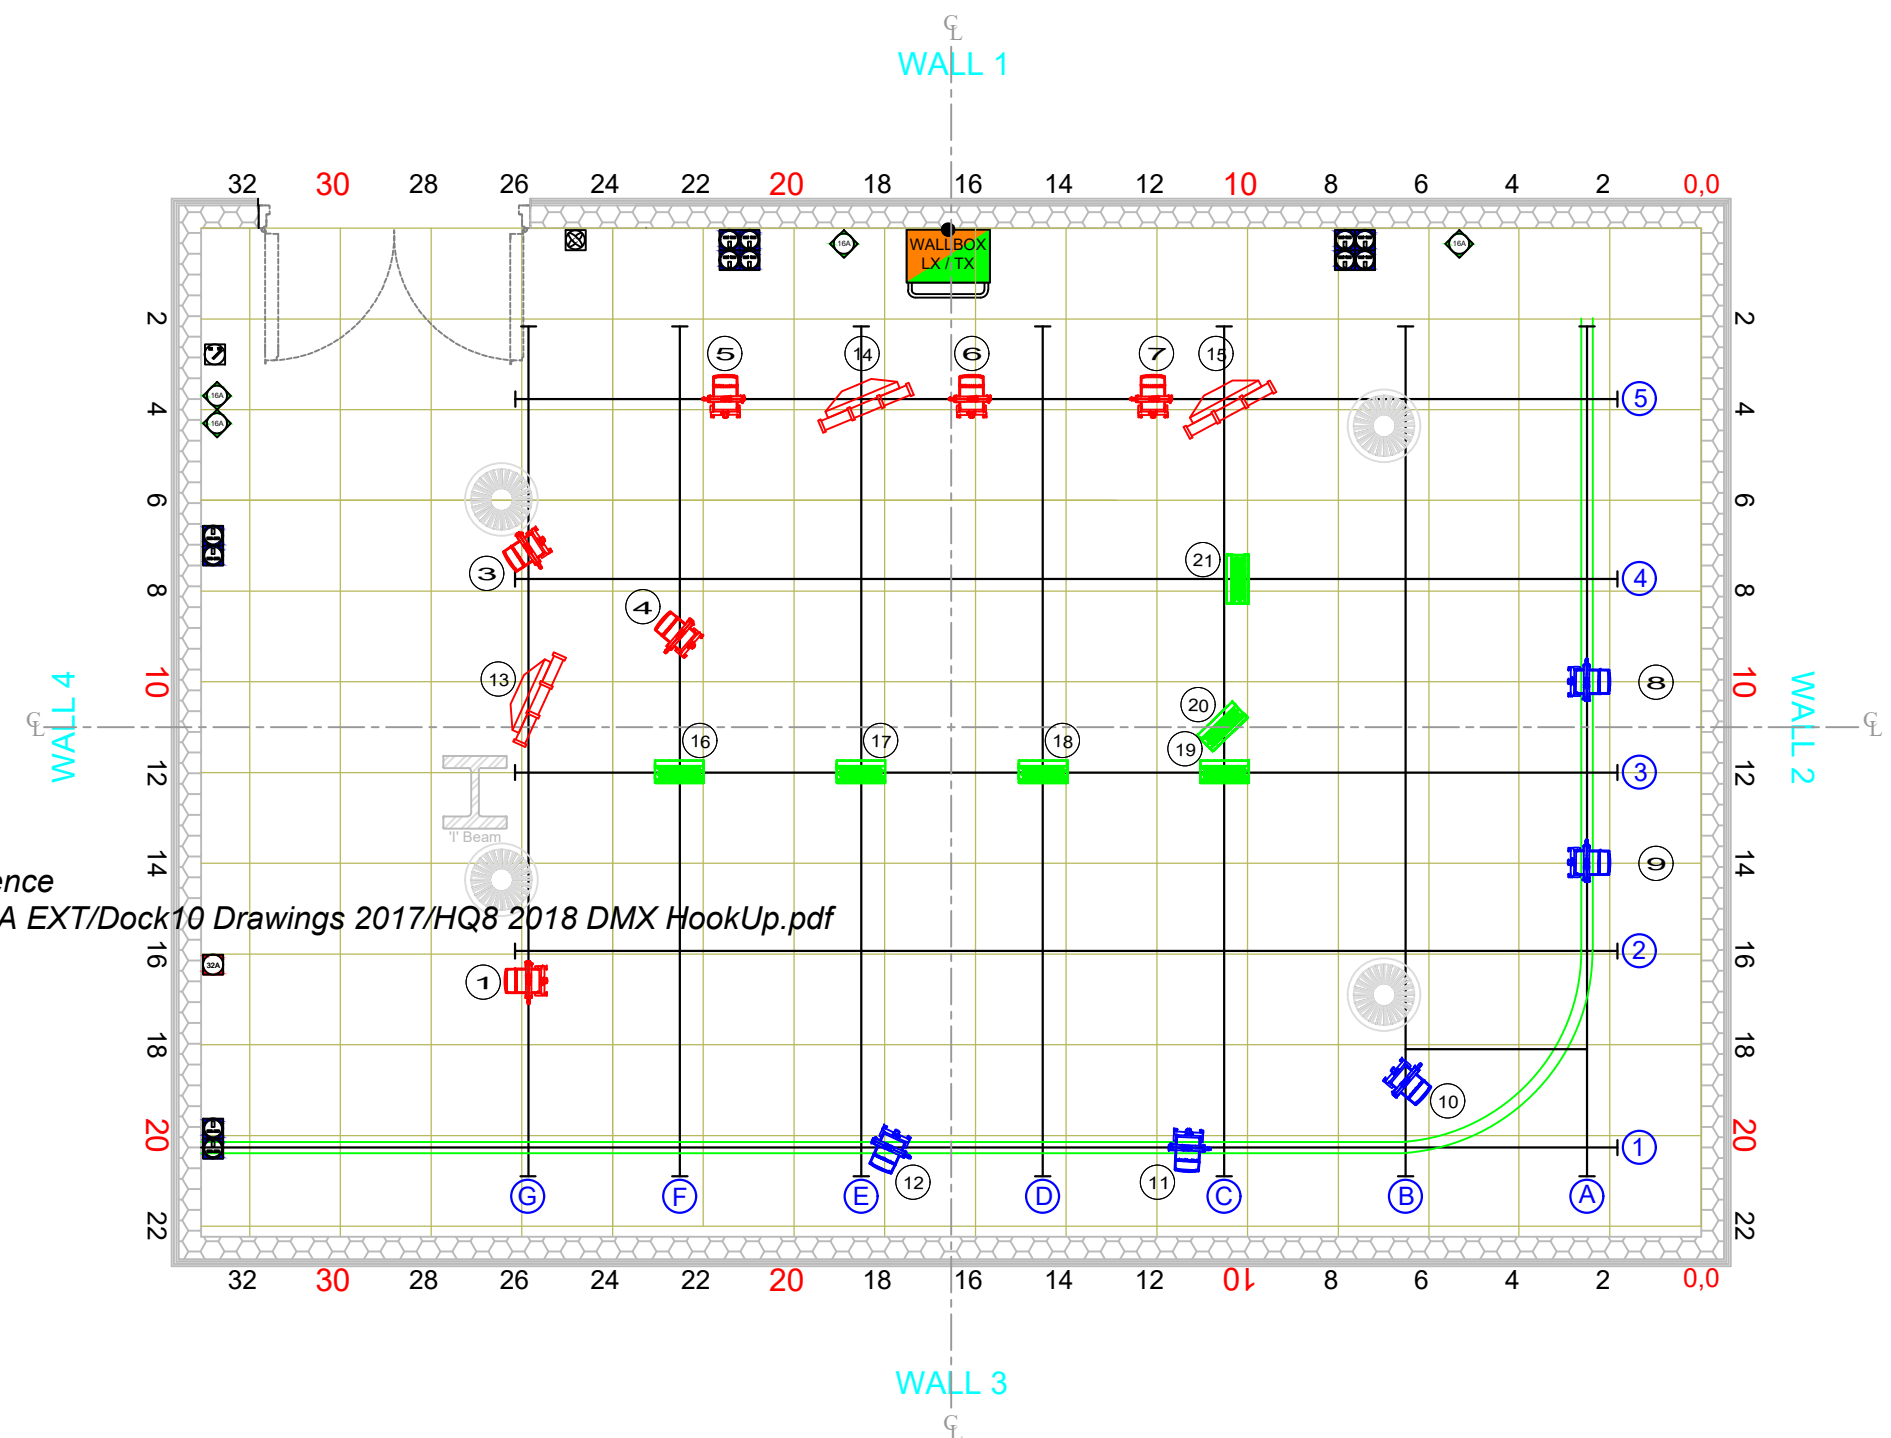
**N.B. MEASUREMENTS ARE INCLUDED AS A GUIDE. PLEASE DOUBLE CHECK ON SITE IF CRITICAL TO PRODUCTION.**

**KEY:**

- Cold Air Switch 
- House Light Switch 
- Ventilation Ducting 
- Facility Panel 
- Chroma-Q Studio Force T 12 Phosphor 
- Prolights Evo160F LED Fresnel 

 



PRODUCTION:
DIRECTOR:
DESIGNER:
DRAWN BY:
PRODUCTION DATE: 4/26/2017

Useful Telephone Numbers	<b>SCALE:</b> 1:50 @ ISO_A3_(420_X_297_MM)
24hr Control Room 0161 855 6400 dock10 office 0161 886 5111 MCR 0161 886 5151	<b>Version:</b> Drafted 06/10/2026, TK



Missing or invalid reference  
 File: /Volumes/TOSHIBA EXT/Dock10 Drawings 2017/HQ8 2018 DMX HookUp.pdf  
 Sheet: 1

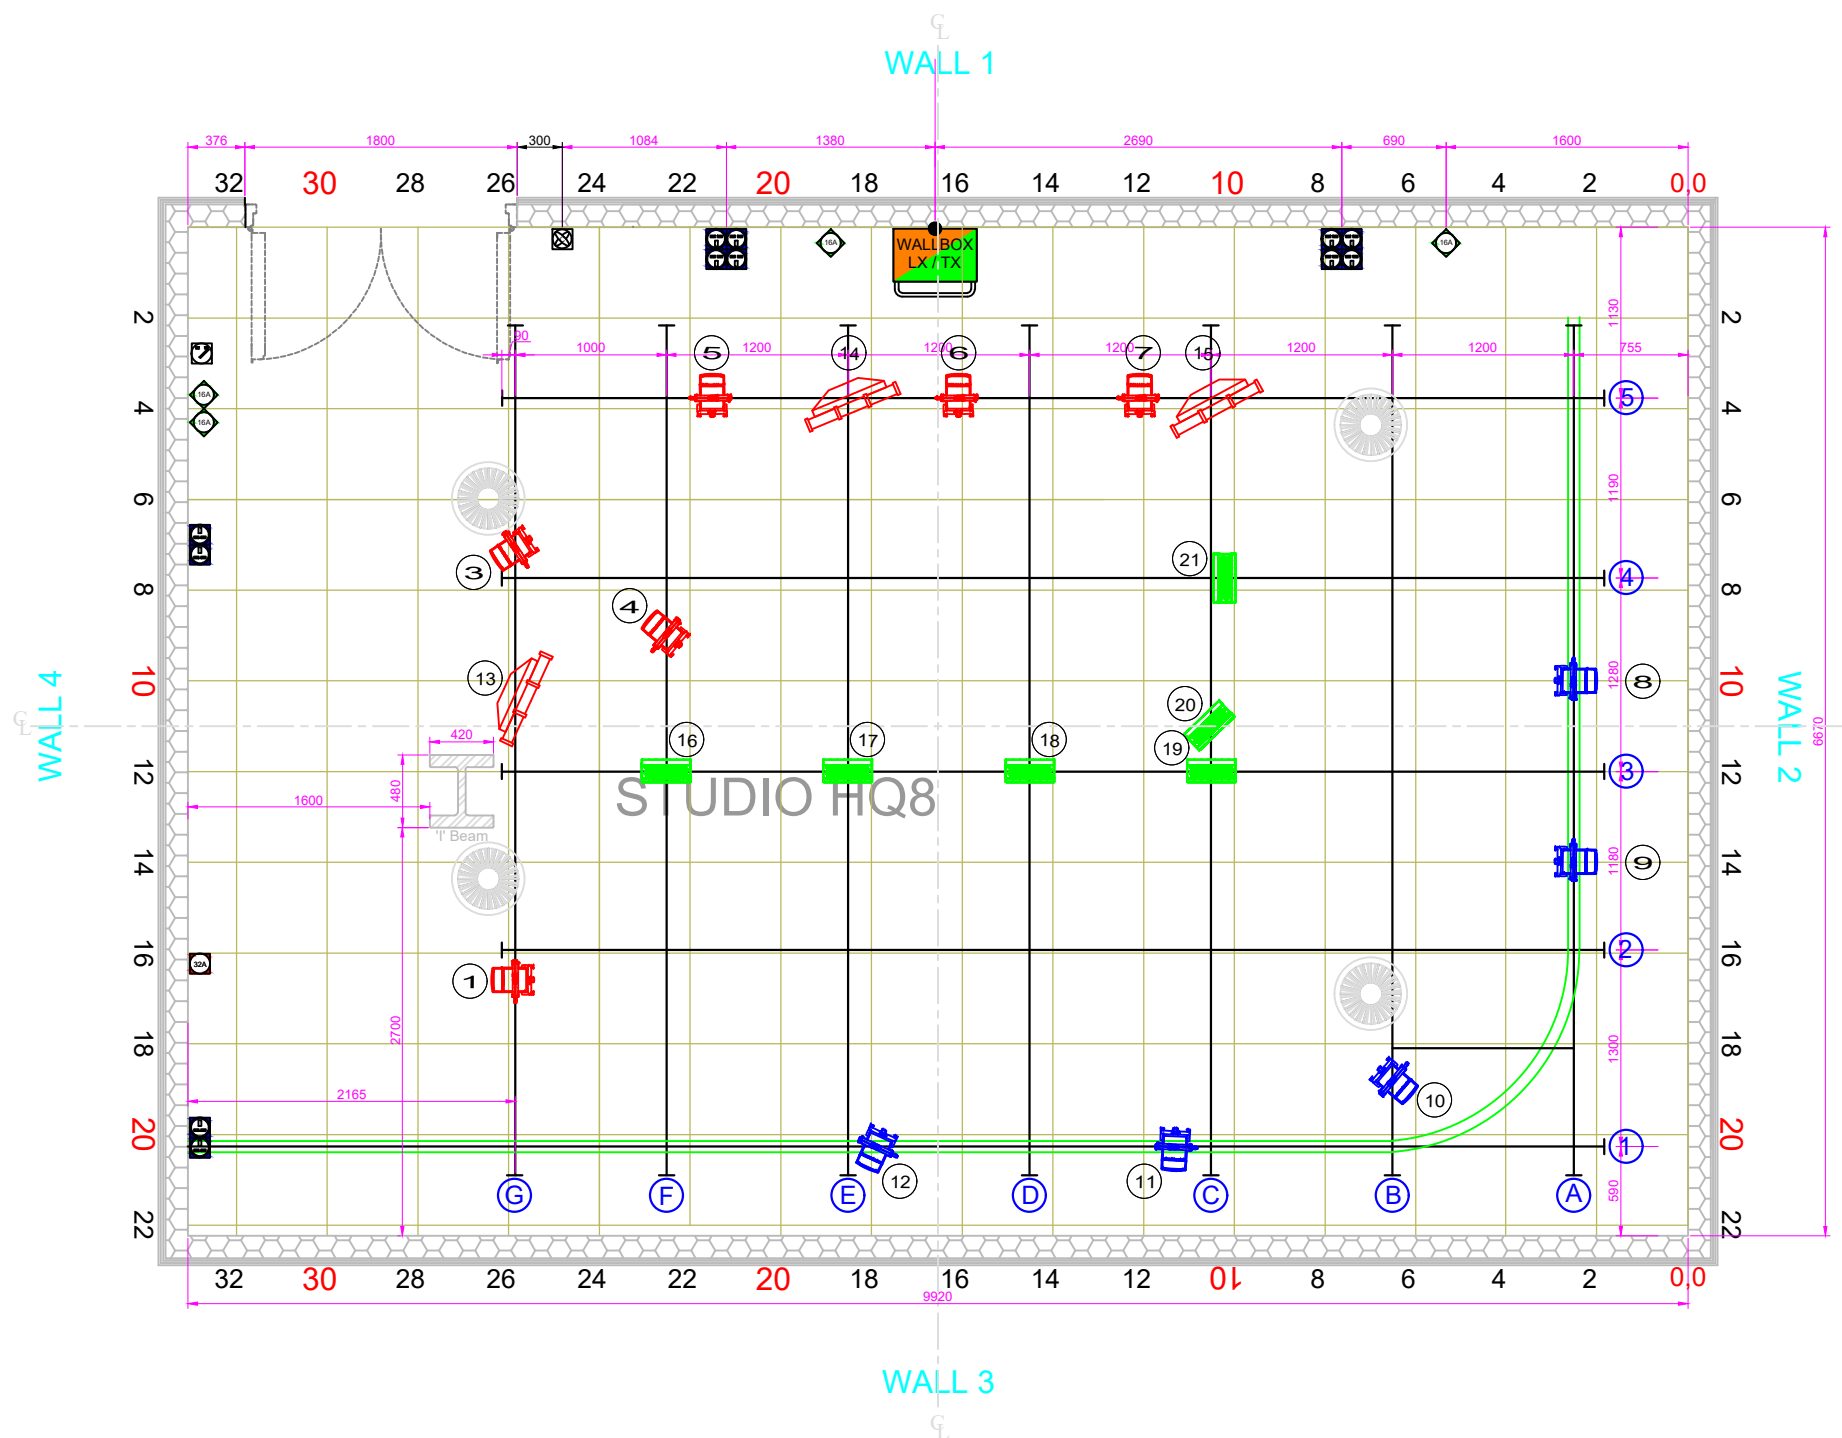
**Fixture Key**

- Chroma-Q Studio Force T 12 Phosphor 
- Prolights Evo160F (Mode STD.P-5 channel with 1/4 CTO (206) 
- Prolights Evo160F (Mode STD.P-5 channel with 1/2 Diff (250) 
- Chroma-Q Space Force (2 Channel Mode) 

# MEDIA CITY

## HQ8 Studio Plan

All information



- STUDIO FLOOR GRID MADE UP OF 600mm SQUARES

- STUDIO WALL 1 TO WALL 3 6.67m
- STUDIO WALL 2 TO WALL 4 9.92m
- STUDIO SPACE 66.17sq m 713sq ft
- CENTRE POINT LOAD ON ANY SCAFF TUBE 50Kg
- NO SIDE LOADING TO THE GRID STRUCTURE AT ANY TIME
- FLOOR IS 22mm TIMBER NOT RESIN BUT CAN BE PAINTED

- NO LADDERS TO BE LEANT AGAINST ANY TUBE

- HEIGHT TO CEILING IS 3.99m
- HEIGHT TO CYC TRACK IS 3.06m
- HEIGHT TO LIGHTING BARRELS IS 3.32m

- 2X CYCLORAMA TRACKS CSO GREEN AND BLACKS AT 3.02m

- SIZE OF LOAD IN DOOR: 1.8m Wide , 2.0m High

- GROUND LEVEL MAINS:

- 1x 32A 3φ
- 4x 16A 1φ
- 12x 13A 1φ

- MAX CORRIDOR RESTRICTION W1.46m, H 2.0m

**N.B. MEASUREMENTS ARE INCLUDED AS A GUIDE. PLEASE DOUBLE CHECK ON SITE IF CRITICAL TO PRODUCTION.**

**KEY:**

- Cold Air Switch**
- House Light Switch**
- Ventilation Ducting**
- Facility Panel**
- Chroma-Q Studio Force T 12 Phosphor**
- Prolights Evo160F LED Fresnel**

PRODUCTION:

DIRECTOR:

DESIGNER:

DRAWN BY:

PRODUCTION DATE: 4/26/2017

Useful Telephone Numbers  
 24hr Control Room 0161 855 6400  
 dock10 office 0161 886 5111  
 MCR 0161 886 5151

**SCALE:**  
 1:50 @  
 ISO\_A3\_(420\_X\_297\_MM)

Unauthorised copying or distribution is prohibited

**Version:**  
 Drafted 06/10/2026, TK